


# NPRA RELIABILITY & MAINTENANCE CONFERENCE MAY 24-27, 2011

FLOOR PLAN SUBJECT  
TO FIRE MARSHALL  
APPROVAL

DRAWINGS AS OF 08/24/10 RPW  
Drawing Started on: 08/16/10 RPW

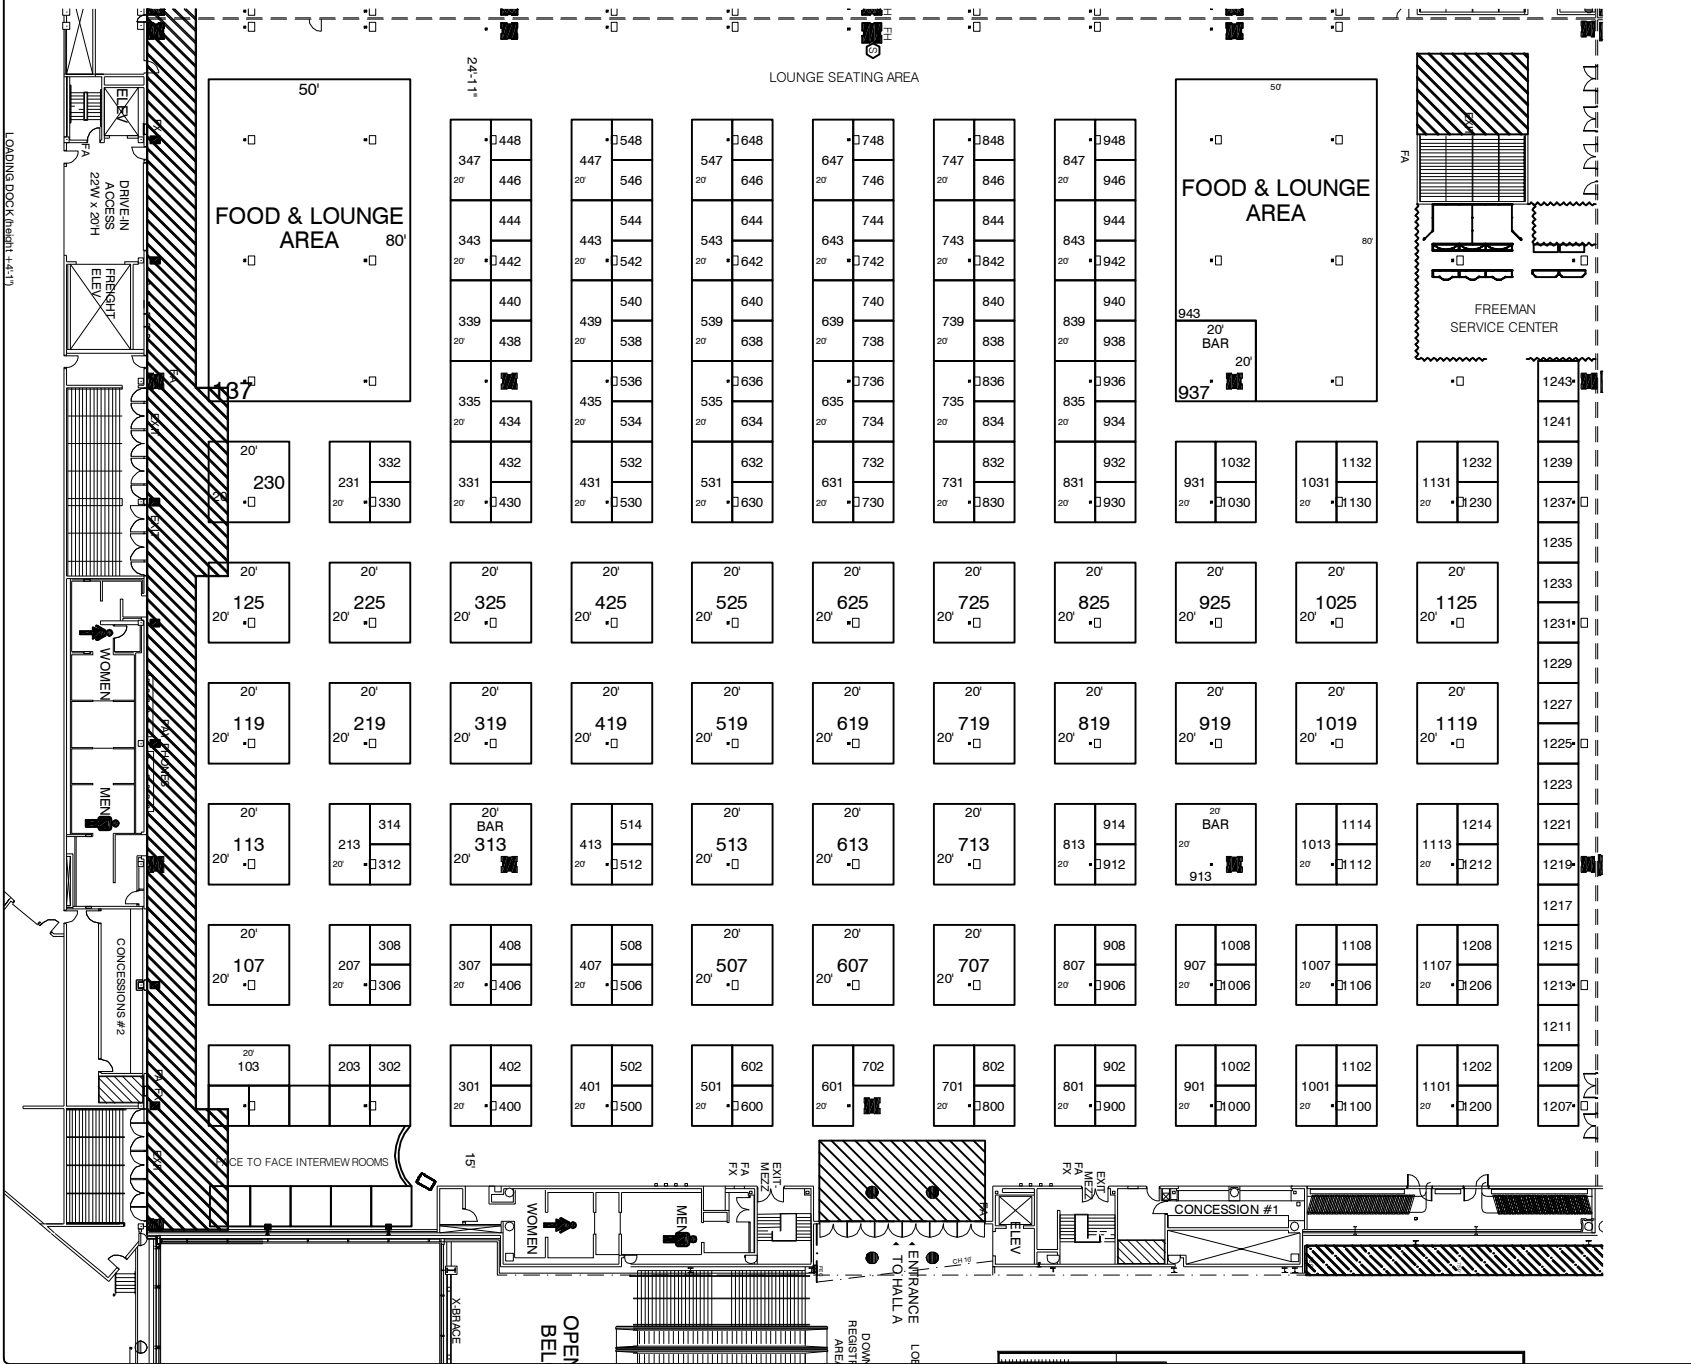

**SHOW LEGEND & BOOTH COUNT**

Hall A as of 08/21/2010

Dimension	Size	Qty	SqFt
10x10	100	129	12,900
10x20	200	56	11,200
20x20	400	33	13,200
50x80	4,000	1	4,000
Custom	400	1	400
Custom	3,600	1	3,600
Totals:			221 45,300

CEILING HEIGHTS  
29'2" TO BEAMS  
36" TO TRUSSES  
40'5" TO CEILING

- BUILDING LEGEND**
- EMERGENCY ACCESS KEEP CLEAR
  - FIRE EXTINGUISHER
  - FIRE ALARM BOX
  - FIRE HOSE CABINET
  - TYPICAL COLUMNS
  - FLOOR UTILITY PORT
  - STAGE POWER
  - GAS TAP 30' OVERHEAD
  - WOMENS RESTROOM
  - MENS RESTROOM
  - TELEPHONE
  - ESCALATOR
  - ELEVATOR
  - FOOD SERVICE
  - STAIRS
- LINETYPE LEGEND**
- ROLL-UP DOORS
  - AIRWALLS

**FREEMAN**  
4493 FLORENCE ST.  
DENVER, COLORADO 80238  
Phone: 303-329-3442  
Fax: 303-307-0529

DENVER  
DRAFTING & DESIGN

File Name: NPRARMCO511.dwg  
Show Name: NPRA Reliability & Maintenance Conference  
Show Dates: MAY 24-27, 2010  
Facility: CCC  
Job Number: TBD  
Acct. Exec: HH

Scale: NTS

**DISCLAIMER**  
EVERY EFFORT WILL BE MADE TO ENSURE THE ACCURACY OF ALL INFORMATION CONTAINED ON THIS FLOOR PLAN. HOWEVER, THE ARCHITECT, ENGINEER, OR OTHER PROFESSIONAL CONSULTANT OF THE FACILITY IS NOT RESPONSIBLE FOR THE DESIGN OR CONSTRUCTION OF THE BUILDING OR FOR THE DESIGN OR CONSTRUCTION OF THE FACILITY. THE ARCHITECT, ENGINEER, OR OTHER PROFESSIONAL CONSULTANT OF THE FACILITY IS NOT RESPONSIBLE FOR THE DESIGN OR CONSTRUCTION OF THE FACILITY. THE ARCHITECT, ENGINEER, OR OTHER PROFESSIONAL CONSULTANT OF THE FACILITY IS NOT RESPONSIBLE FOR THE DESIGN OR CONSTRUCTION OF THE FACILITY. THE ARCHITECT, ENGINEER, OR OTHER PROFESSIONAL CONSULTANT OF THE FACILITY IS NOT RESPONSIBLE FOR THE DESIGN OR CONSTRUCTION OF THE FACILITY.